




Jennings Hackler and Partners, Inc.

4131 North Central Expressway  
Suite 400  
Dallas, Texas 75204-3191  
214.528.8644 Telephone  
214.528.9226 Telecopier  
mailto:info@jennings-hackler.com

CONSULTANT  
**SEI**  
Structural Enginry Inc.  
2735 Villa Creek Drive, #260  
Dallas, Texas 75254

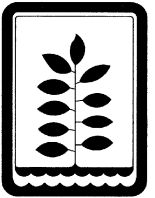

ENVIRONMENTAL SERVICES BUILDING

NORTH TEXAS MUNICIPAL WATER DISTRICT

505 East Brown Street  
Wylie, Texas

FLOOR PLAN

SCALE  
1/8" = 1'-0"



ISSUE DATE  
June 14, 2006

REVISIONS

PROJECT NO.  
05201  
TOTAL SHEETS SHEET NO.

S2.1

- Pier 1 23 EA
- Pier 2 4 EA
- Pier 3 20 EA
- Pier 4 3 EA
- Pier 5 6 EA
- GB 6/S3.2 536 LF
- GB 8/S3.2 46 LF
- GB 7/S3.2 60 LF
- GB 10/S3.2 24 LF
- GB 16/S3.1 27 LF
- GB 9/S3.2 11 LF
- GB 15/S3.2 16 LF
- GB 18/S3.2 24 LF
- GB 5/S3.2 35 LF
- GB 17/S3.1 36 LF
- GB 11/S3.1 18 LF
- GB 19/S3.2 66 LF
- GB 14/S3.2 (1) 99
- GB 14/S3.2 (2) 99 LF
- Building Slab 5" 21,315 SF
- GB 13/S3.2 25 LF

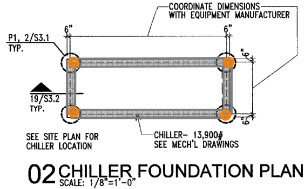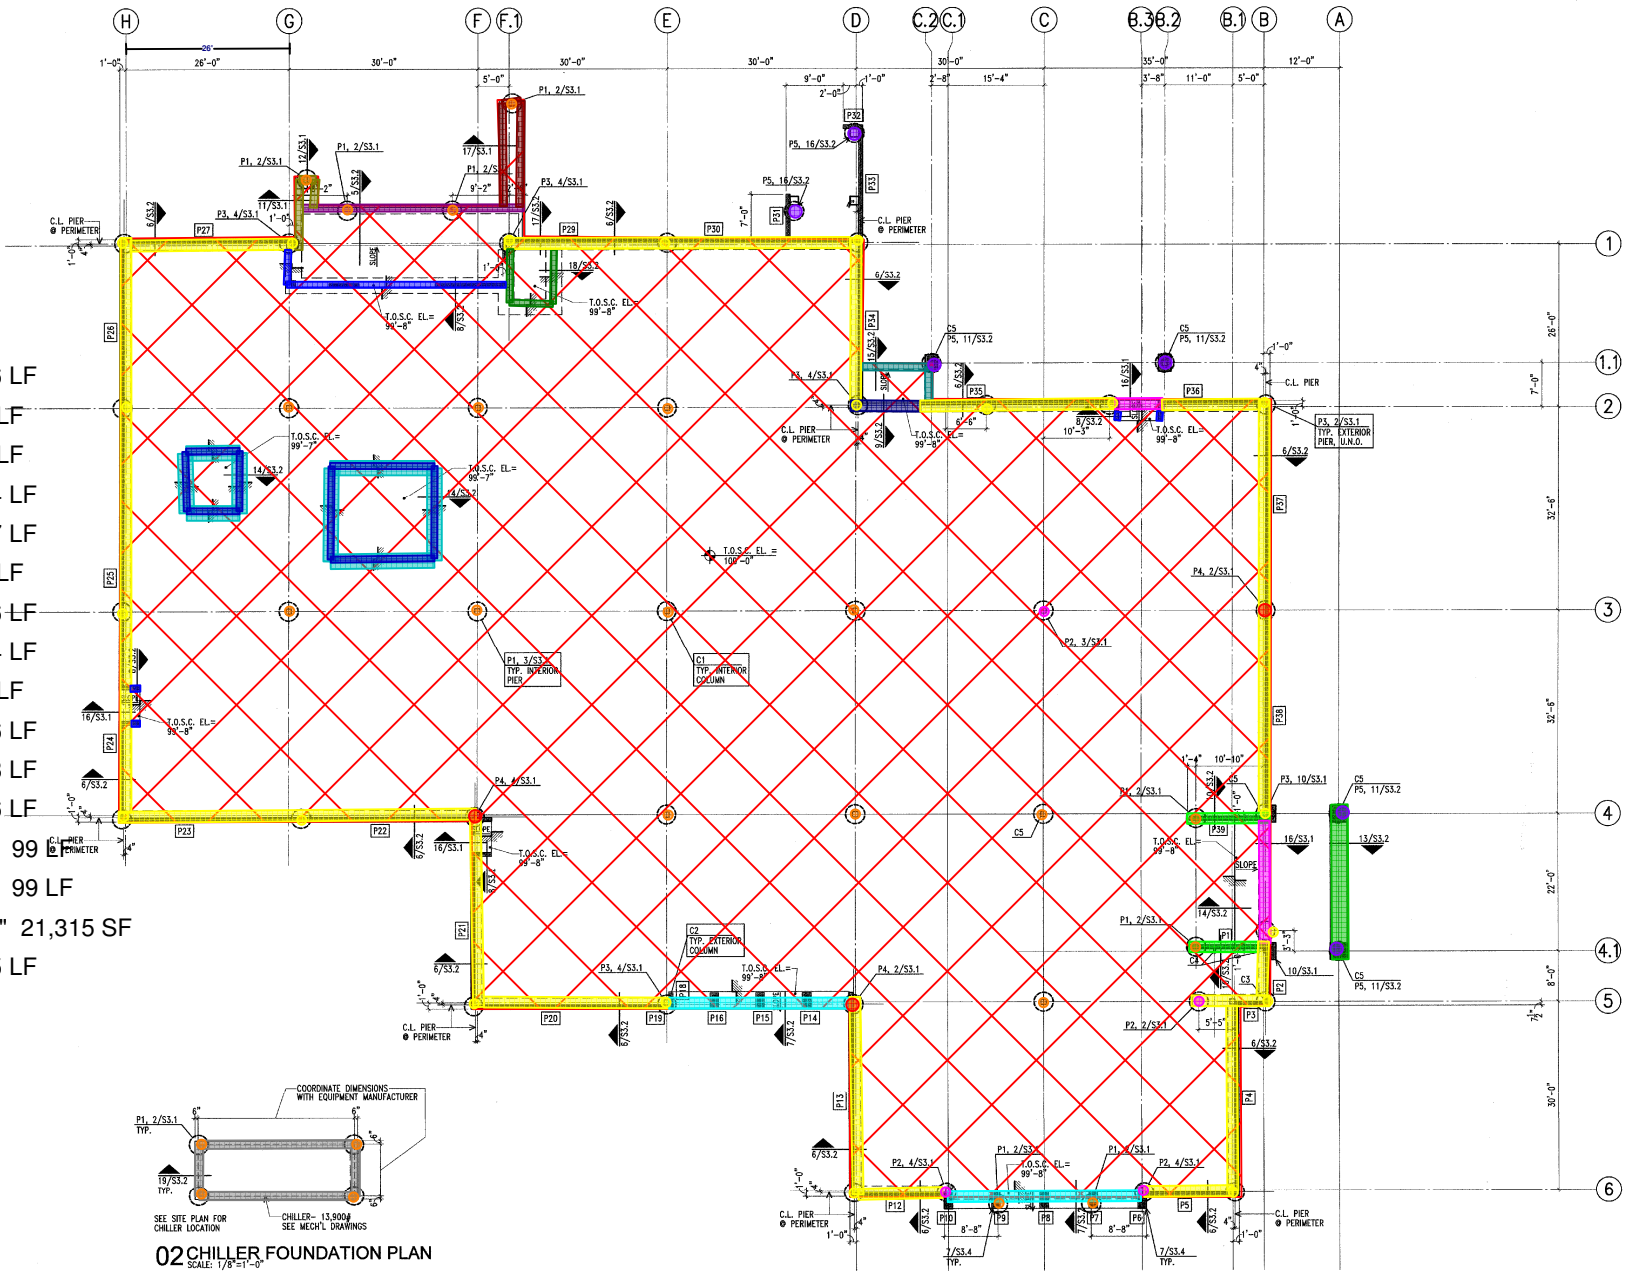

01 FLOOR PLAN  
SCALE: 1/8" = 1'-0"

